


2 CUSTOMER SERVICE KIOSK
E4.03 SCALE: 3/8" = 1'-0"

NOTES:

- ALL CAT-5E CABLE SHALL BE BELDEN 1212 CMR CAT-5E 4 PAIR 24 AWG (BELDEN 1200 DATATWIST CABLE SERIES).
- ALL CAT 5 CABLE TO BE INSTALLED IN 3/4" CONDUIT UNLESS NOTED OTHERWISE.

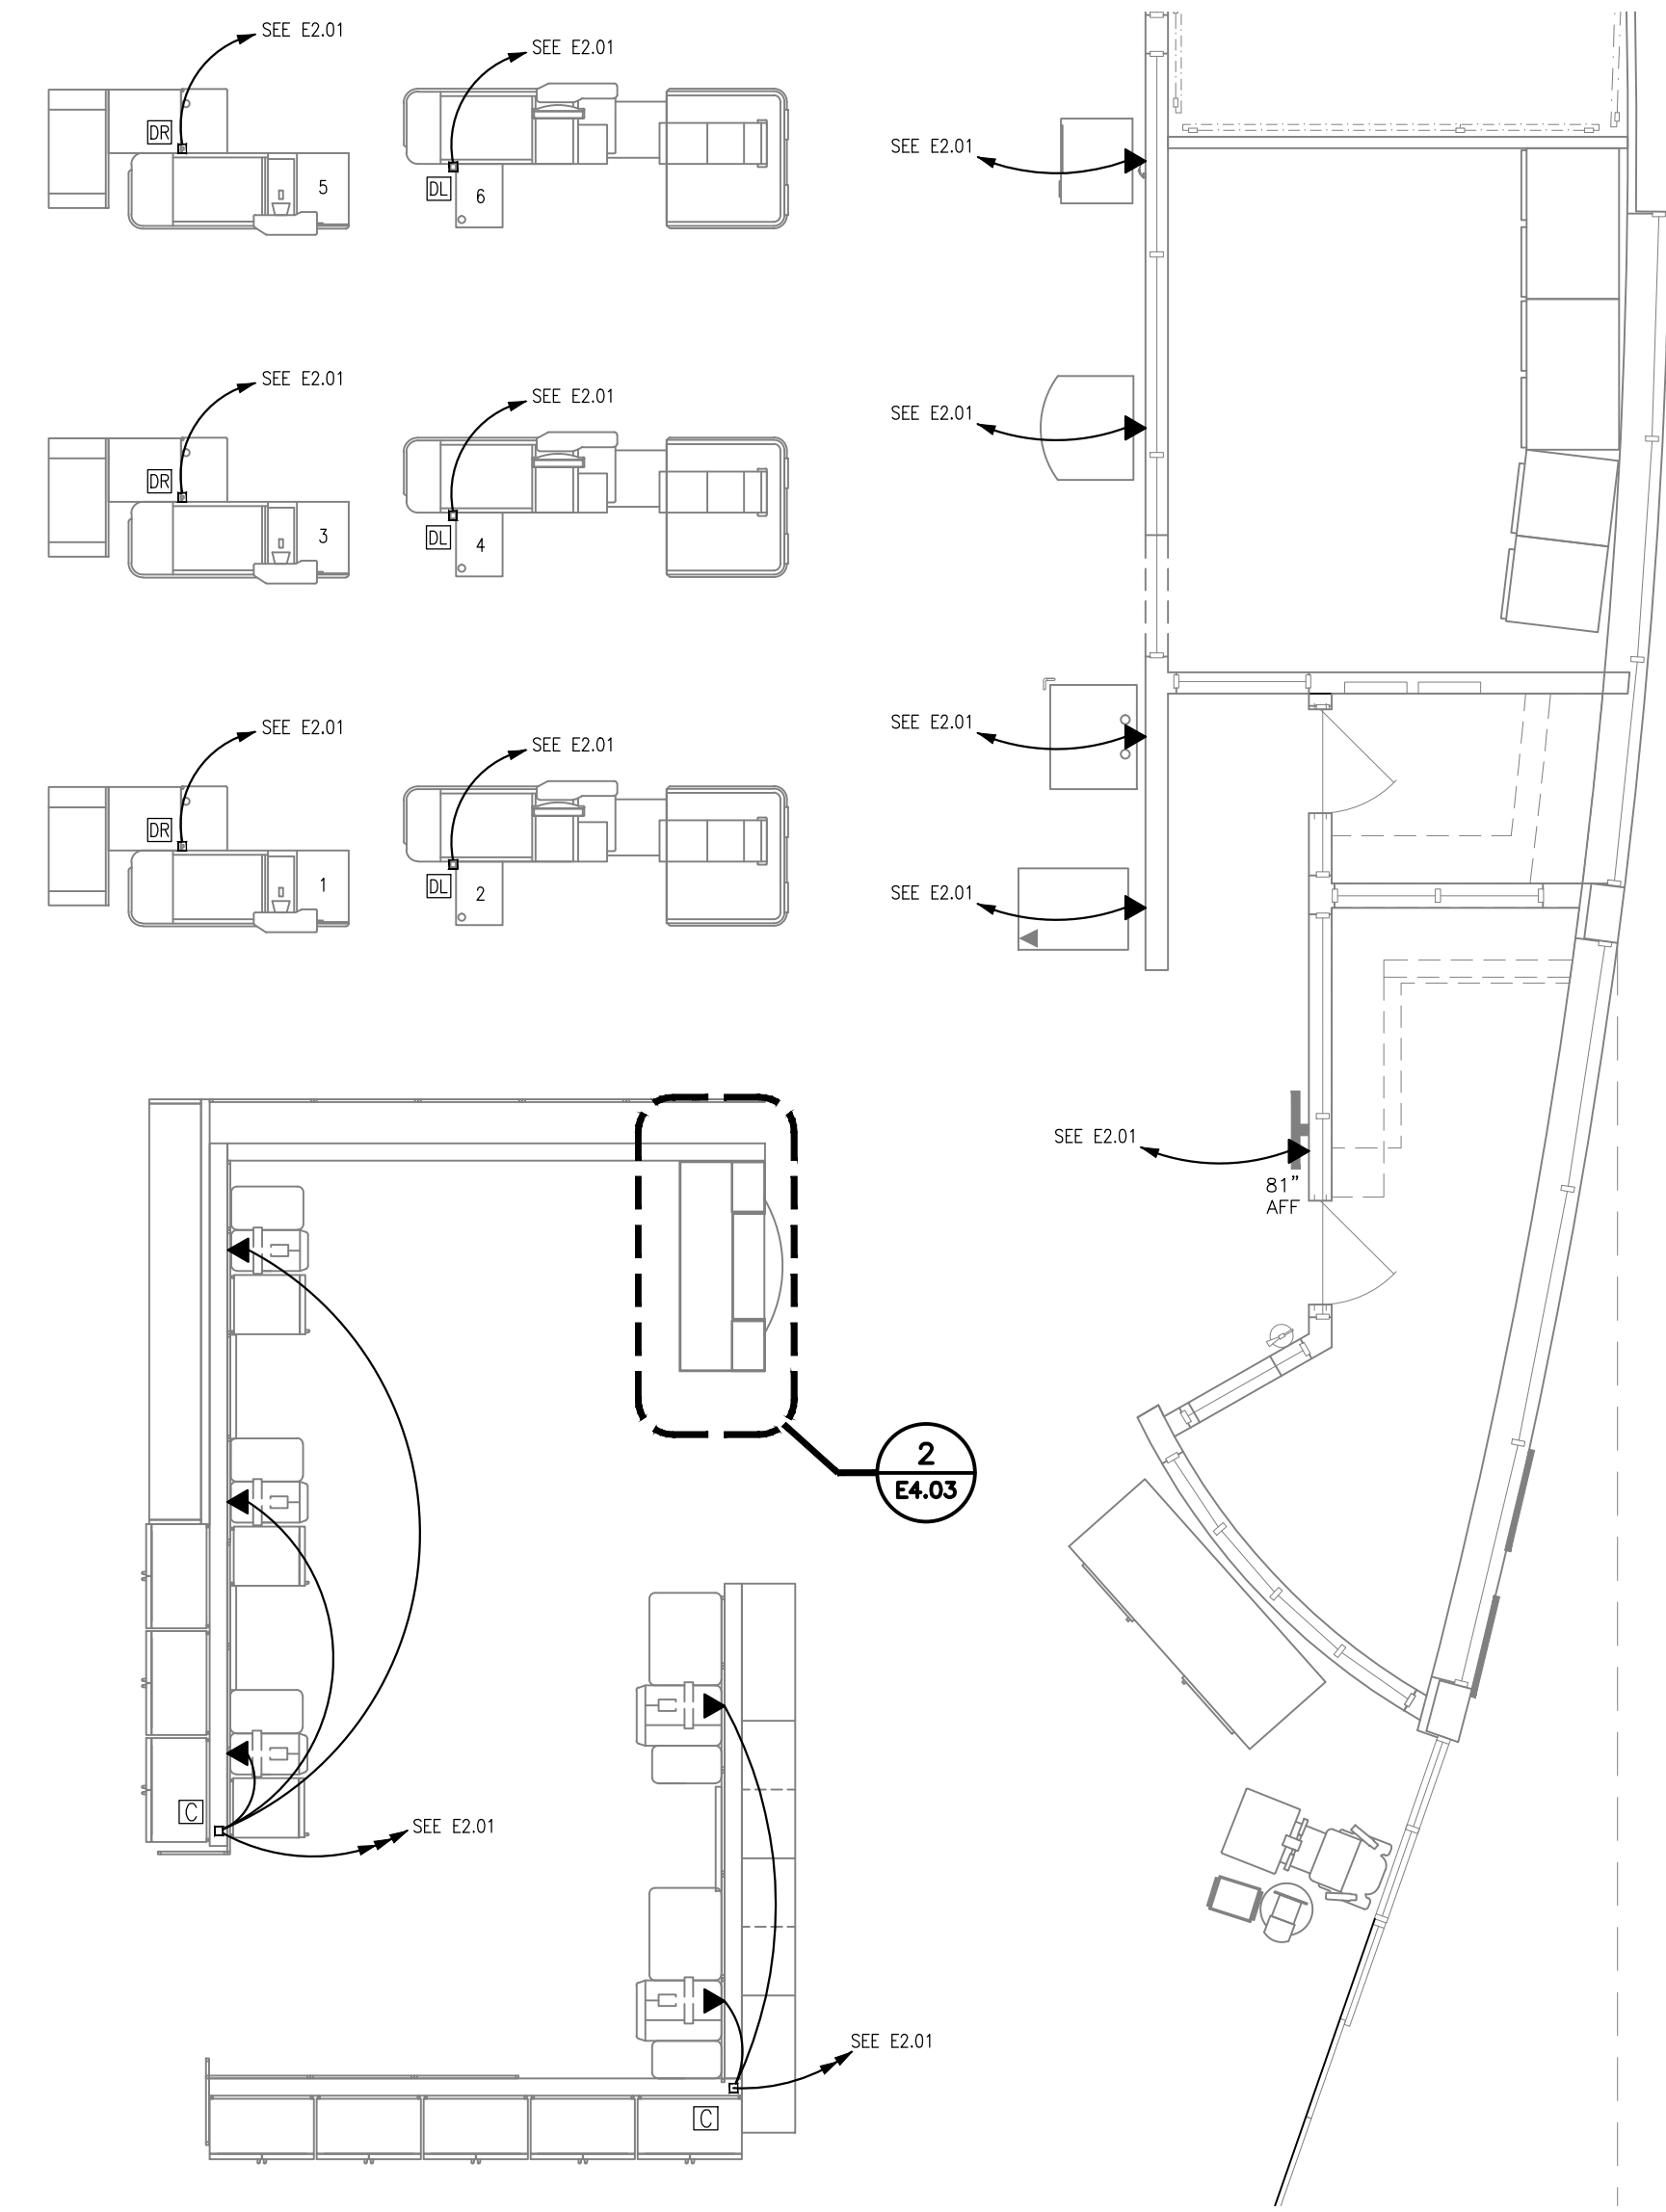

1 ENLARGED ELECTRICAL POWER PLAN
E4.03 SCALE: 3/16" = 1'-0"

PROFESSIONAL'S SEAL:



08/29/2022
 CORPORATE SEAL:

REVISIONS
 NO DATE REMARKS

PROJECT NO: 1657/FLMK22
 DATE: 08/29/2022

34 OF 40
E4.03

CUSTOMER SERVICE, WORKROOM, AND CHECK OUT COMMUNICATION PLAN
 CHECKED: DOD DRAWN: BDB