



POWER PLAN KEY NOTES

1. COORDINATE MOUNTING HEIGHT WITH FOOD LION CONSTRUCTION MANAGER.
2. MATCH MOUNTING HEIGHT OF EXISTING BELOW COUNTER OUTLETS.
3. EXISTING DIRTY POWER OUTLET.
4. EXISTING CLEAN POWER OUTLET.
5. EXISTING 4-PORT DATA OUTLET.
6. EXISTING TELEPHONE OUTLET.

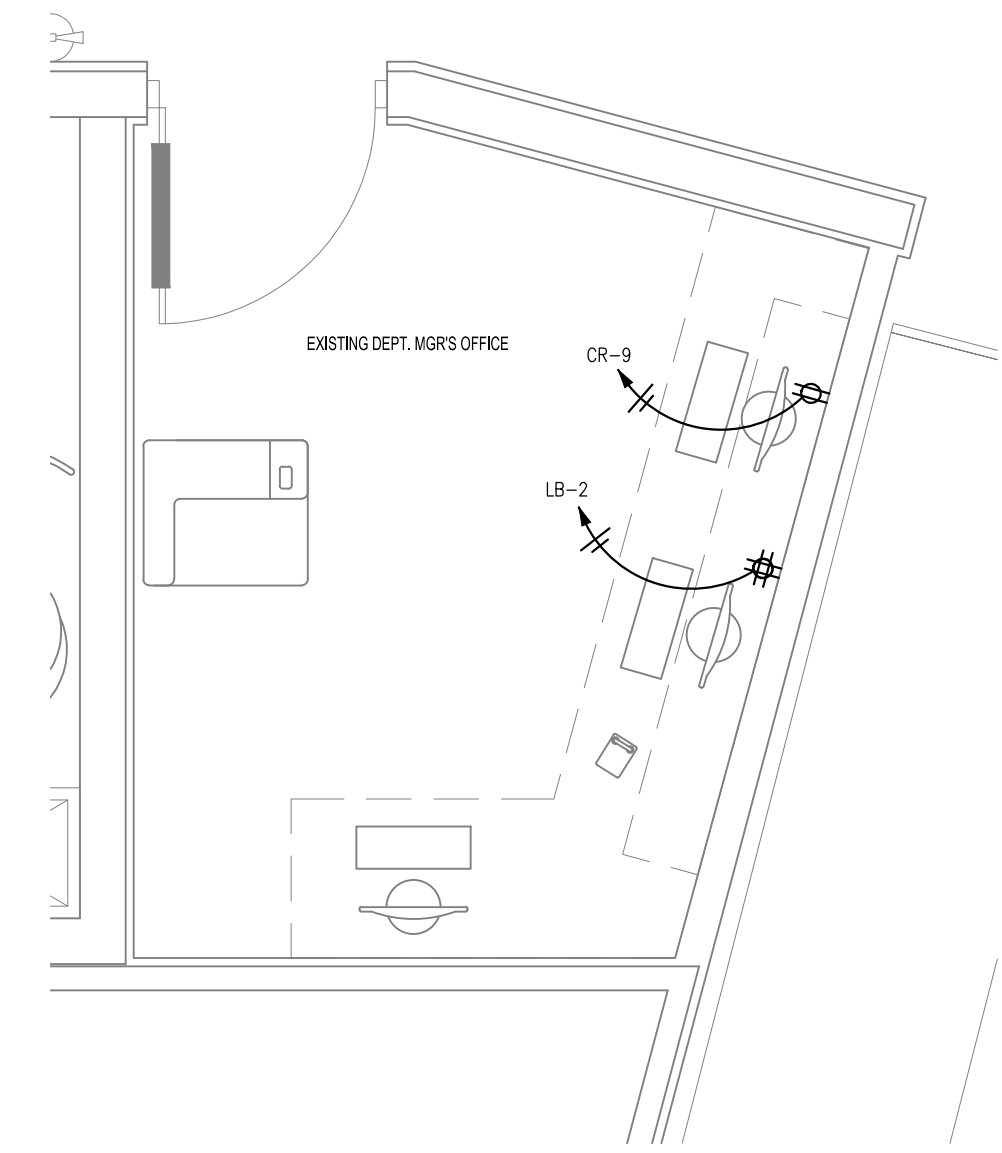

1 DEPARTMENT MANAGERS OFFICE PLAN
E4.04 / SCALE: 3/8" = 1'-0"

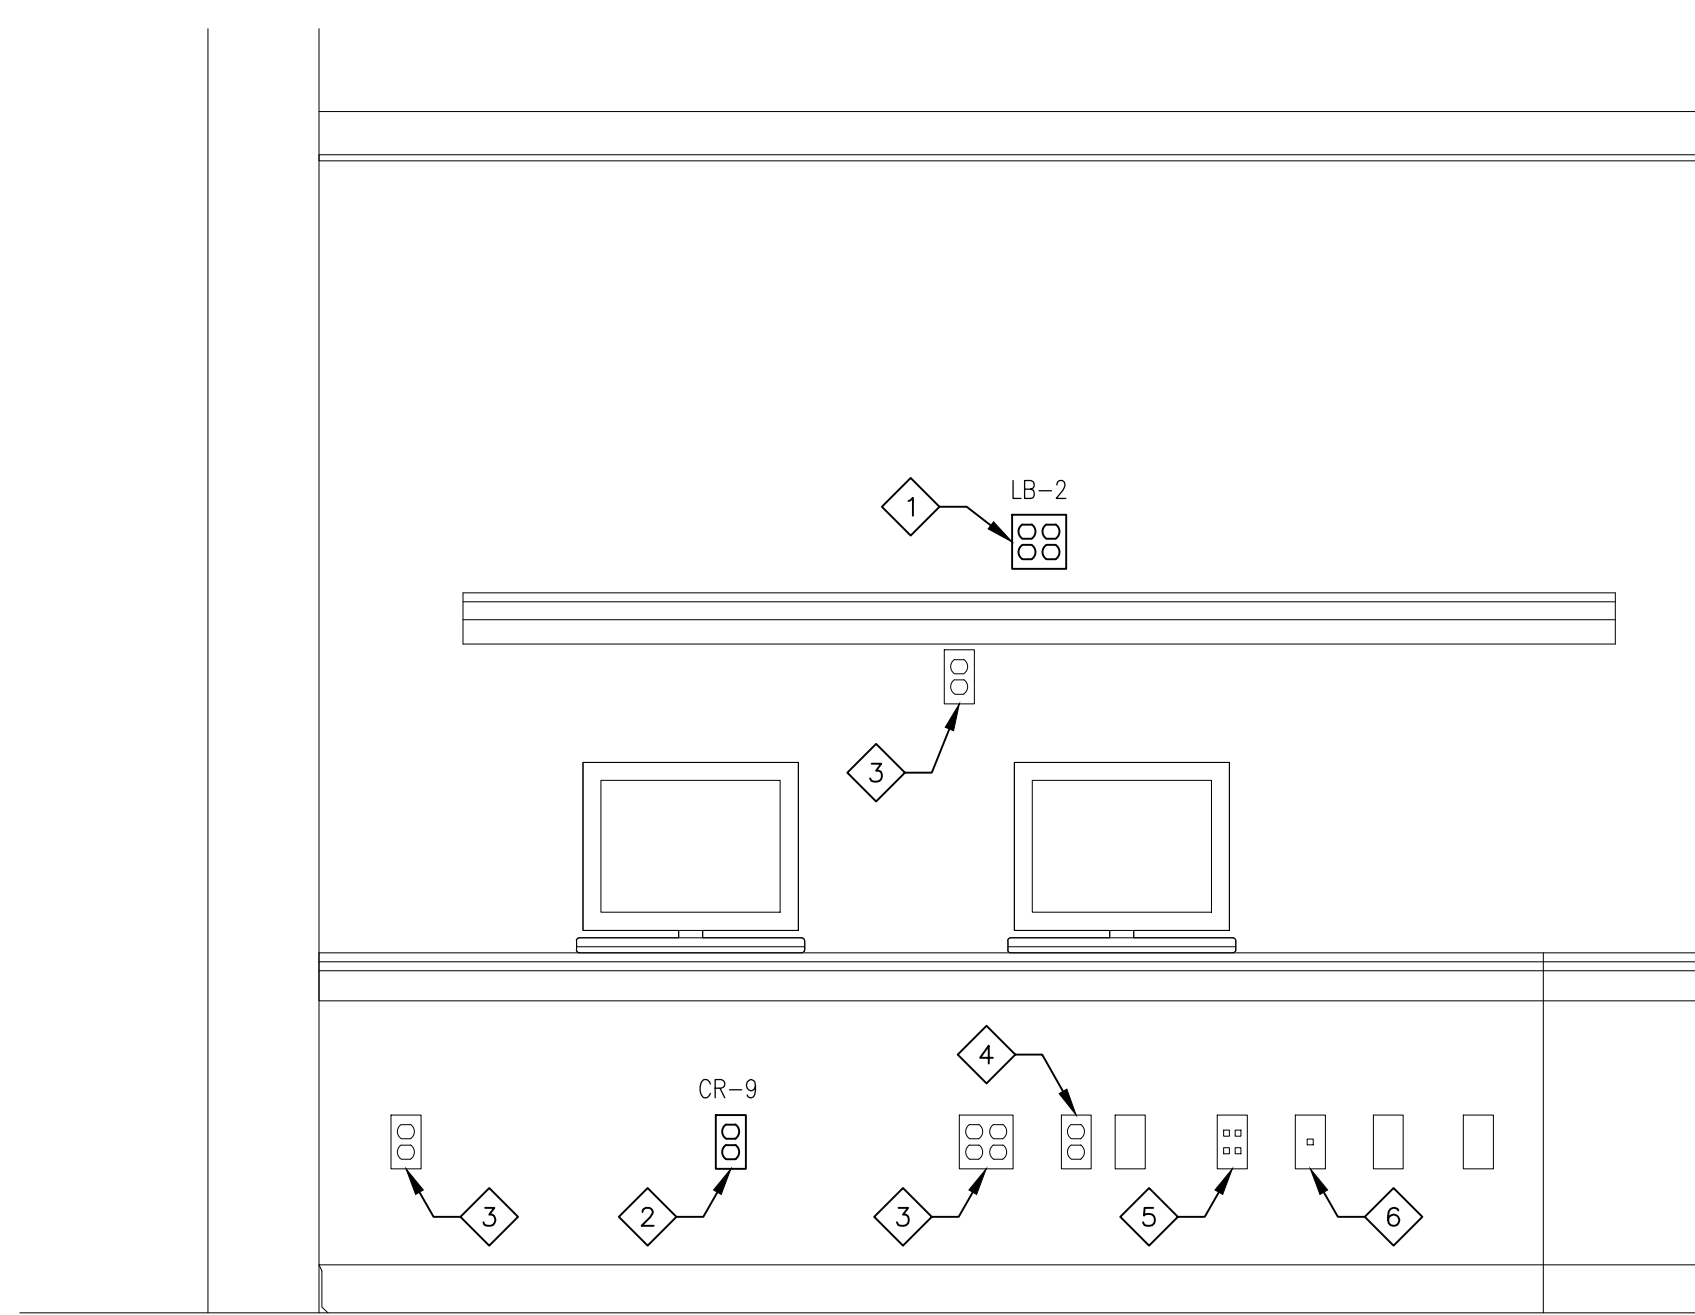

2 DEPARTMENT MANAGERS OFFICE ELEVATION
E4.04 / NOT TO SCALE

PROFESSIONAL'S SEAL:



08/29/2022

CORPORATE SEAL:

REVISIONS
NO DATE REMARKS