


LIGHTING FIXTURE SCHEDULE

FIXTURE TYPE	DESCRIPTION	MANUFACTURER	MODEL NUMBER	WATTS	VOLTS	NOTES
BL	LED LINEAR CURVE Fixture, 37w, 4650 lumens, 35K	Elite	4-OC1-LED-5000L-DIM10-MVOLT-35K-85	37	120	
BLE	LED LINEAR CURVE Fixture, 37w, 4650 lumens, 35K w/emeg battery backup	Elite	4-OC1-LED-5000L-DIM10-MVOLT-35K-85-0-EMG-LED	37	120	
HB	LED High Bay	Cree	KBL-A-UV-M-40K-8-UL-ML with white acrylic reflector	142	120	
LGP	8' Linear PREMIUM LED strip; ceiling mounted. No reflector.	Power Concepts	P-OC960240L16A301 (dimming for lay-in ceilings over 14' AFF)	90	120	
LGP	4' Linear PREMIUM LED strip; ceiling mounted. No reflector.	Power Concepts	P-OC480120L16A301 (dimming for lay-in ceilings over 14' AFF)	50	120	
LSP	8' Linear PREMIUM LED strip; suspended. No reflector.	Power Concepts	P-OC960240L16A301 with OCLS-2 Hanging Kit (dimming for open ceilings)	90	120	
LSP	4' Linear PREMIUM LED strip; suspended. No reflector.	Power Concepts	P-OC480120L16A301 with OCLS-2 Hanging Kit (dimming for open ceilings)	50	120	
MXL	48" PLUG-AND-PLAY LIGHTBAR 3500K	MaxLite	74959 - 48LB35	24	MVOLT	
RTB	Recessed Downlight	Sylvania	LED/R18/3000/935	40	120	
XCL	LED Egress Light	Mule	MAKO-LED ADEM DB	6	120	

LIGHT FIXTURES SHALL BE MANUFACTURED BY LITHONIA UNLESS NOTED OTHERWISE. PURCHASE FROM SYLVANIA AT THE NATIONAL CONTRACT PRICE. FOR PURCHASE, CONTACT SYLVANIA AT 1-800-573-1514 EXT. 0066. THE ELECTRICAL CONTRACTOR SHALL BE RESPONSIBLE FOR VERIFYING ALL QUANTITIES, RATINGS, LENGTHS...ETC. ANY DISCREPANCIES SHALL BE RESOLVED WITH SYLVANIA PRIOR TO BID. CONTRACTOR SHALL BE RESPONSIBLE FOR ANY ADDITION TO THE BILL OF MATERIALS DUE TO LOCAL, STATE GOVERNMENTAL CODES.

- LIGHT FIXTURE SCHEDULE NOTES
- ALL LIGHT FIXTURES (FLUORESCENT AND LED) AND LAMPS SHALL BE PURCHASED FROM SYLVANIA LIGHTING SERVICES CORP. LIGHTING DESIGN AND PROJECT MANAGEMENT DEPARTMENT, 200 MIDWAY PARK DRIVE, MIDDLETON, NY 10940 AT THE NATIONAL CONTRACT PRICE. FOR PURCHASE, CONTACT LISA B. MASTIN AT 1-800-573-1514 EXT. 0066 EMAIL: LisaB.Mastin@osram.com. ALL FIXTURES SHALL BE INSTALLED AND POWERED BY THE ELECTRICAL CONTRACTOR. THE ELECTRICAL CONTRACTOR SHALL BE RESPONSIBLE FOR VERIFYING ALL QUANTITIES, RATINGS, LENGTHS, ETC.
 - SEE SHEET E1.01 FOR MOUNTING HEIGHTS OF ALL LIGHTING FIXTURES. COORDINATE CABLE MOUNTING LENGTH WITH MOUNTING HEIGHT OF FIXTURE.
 - INSTALL 'SHEEP' CLIPS ON BOTH SIDES OF EACH ROW OF FIXTURES. PROVIDE BLACK MC POWER FEED. TIE WRAP MC CORD NEATLY TO AIRCRAFT CABLE.
 - FIXTURE TO BE MOUNTED ON TOP OF REFRIGERATED CASE. MOUNT FIXTURE 24" FROM CENTER OF FIXTURE TO FACE OF WALL. POSITION REFLECTOR TO FACE THE WALL.
 - ALL LAMPS SHALL BE MANUFACTURED BY GENERAL ELECTRIC, SYLVANIA OR PHILIPS, UNLESS NOTED OTHERWISE.
 - SUSPEND QZAS FIXTURES WITH AIRCRAFT CABLE. PROVIDE WHITE MC CABLE POWER FEED. TIE WRAP MC CABLE NEATLY TO AIRCRAFT CABLE.
 - PROVIDE TUBE SHIELDS FOR ALL LAMPS IN THE PRODUCE PREP AND SALES AND ALL FIXTURES IDENTIFIED WITH "TS".
 - MOUNTED TO BACK OF BULKHEAD.

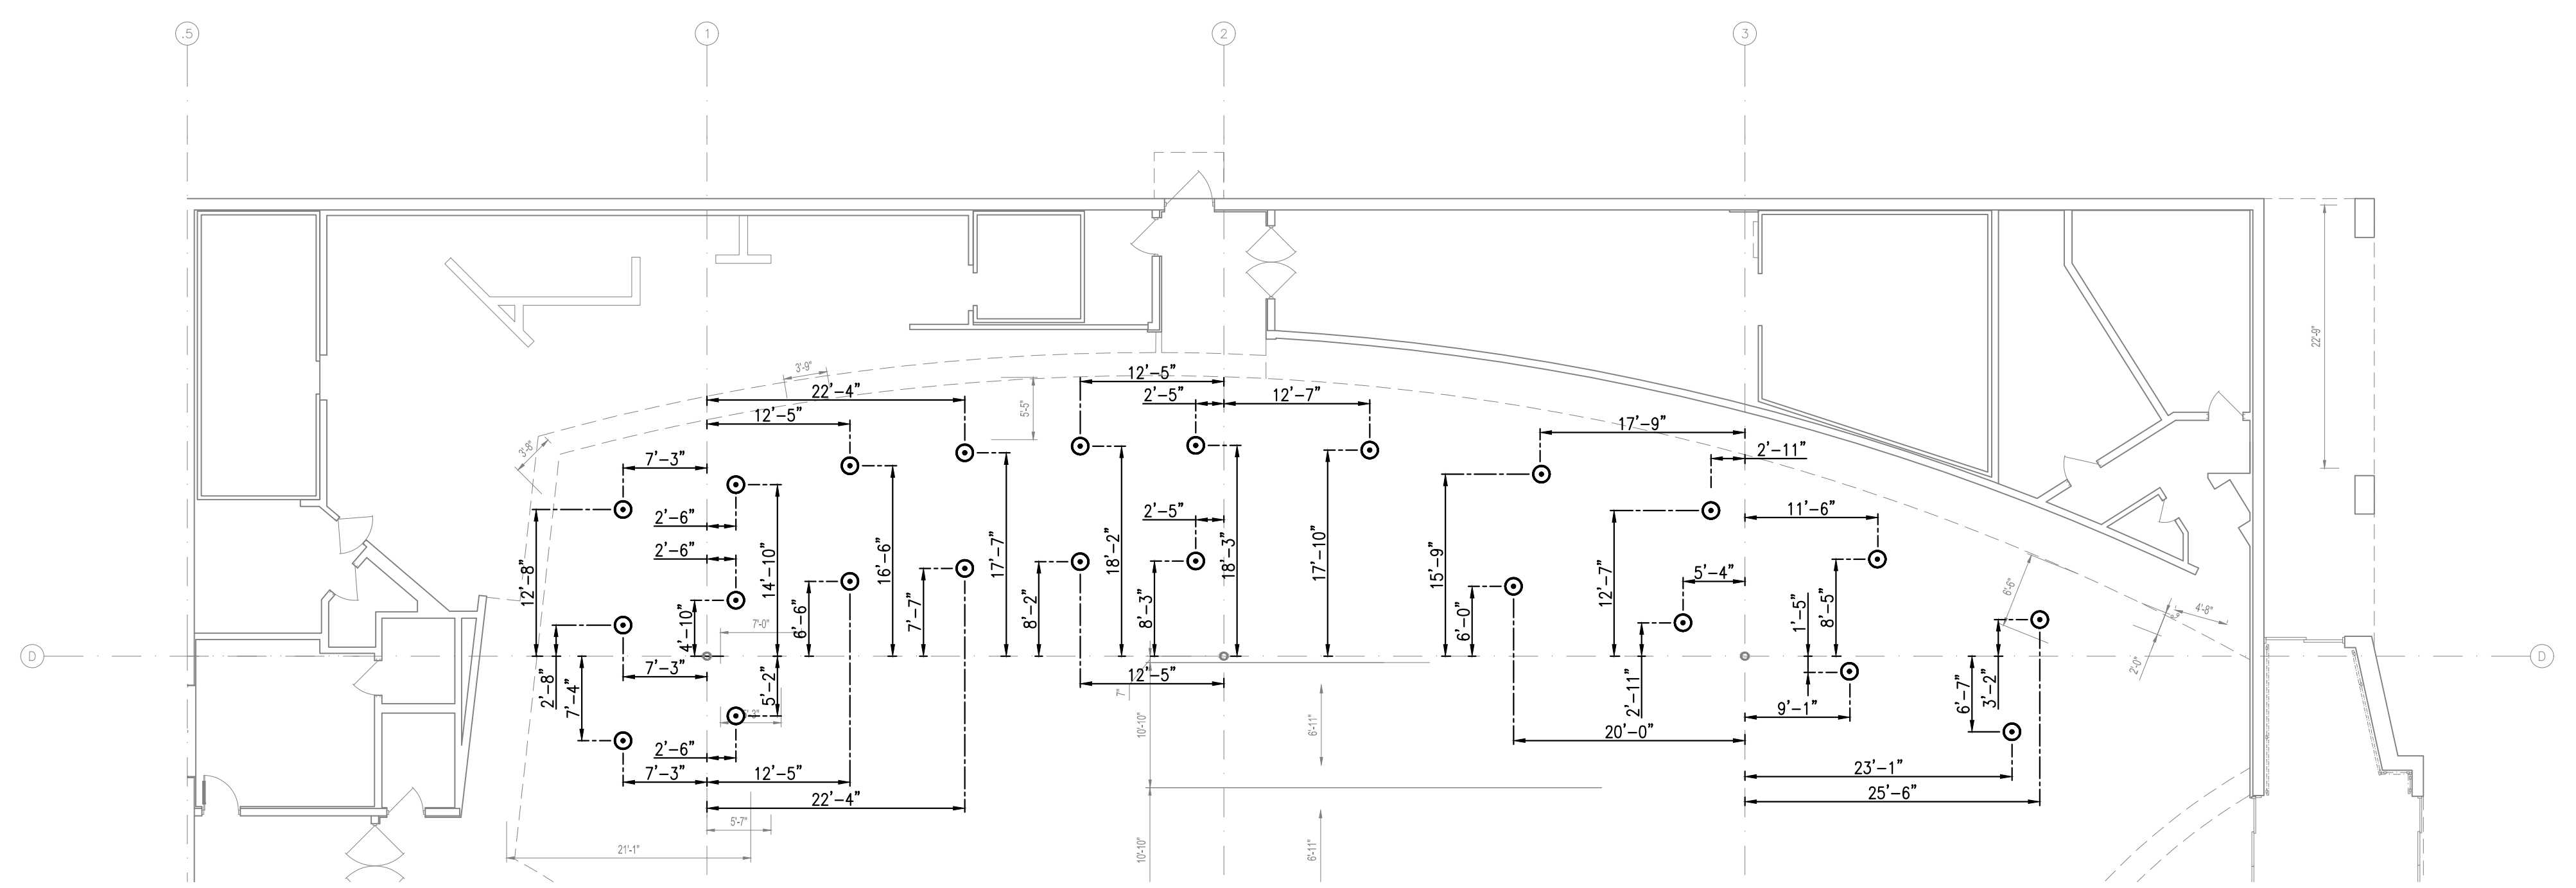

3 PRODUCE AND D/B SALES - FIXTURE TYPE "HB" DIMENSION PLAN
E1.01 SCALE: 3/32" = 1'-0"

PROFESSIONAL'S SEAL:



CORPORATE SEAL:

REVISIONS
NO DATE REMARKS

PROJECT NO: 1657/FLMK22
DATE: 08/29/2022

38 OF 40
E6.02

ELECTRICAL SCHEDULES & DIAGRAMS

CHECKED: DOD DRAWN: DOD