


PROFESSIONAL'S SEAL:

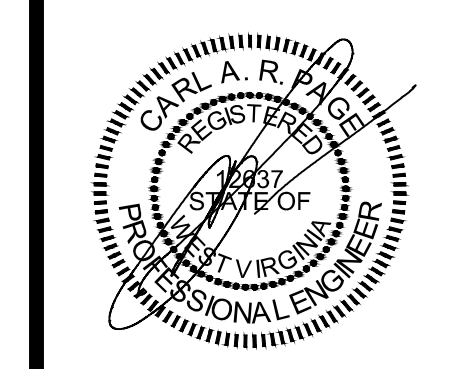

CORPORATE SEAL:

NO.	DATE	REMARKS
00/00/00		COMMENTS

END


FOOD LION REMODEL STORE #807
 70 MORGAN SQ, SUITE 1
 BERKELEY SPRINGS, WV

PROJECT NO: 0807FLMK20
 DATE: 02/11/2020

42 OF 48

E4.03

CUSTOMER SERVICE, WORKROOM, & CHECK OUT COMMUNICATION PLAN
 CHECKED: DOD DRAWN: DFH

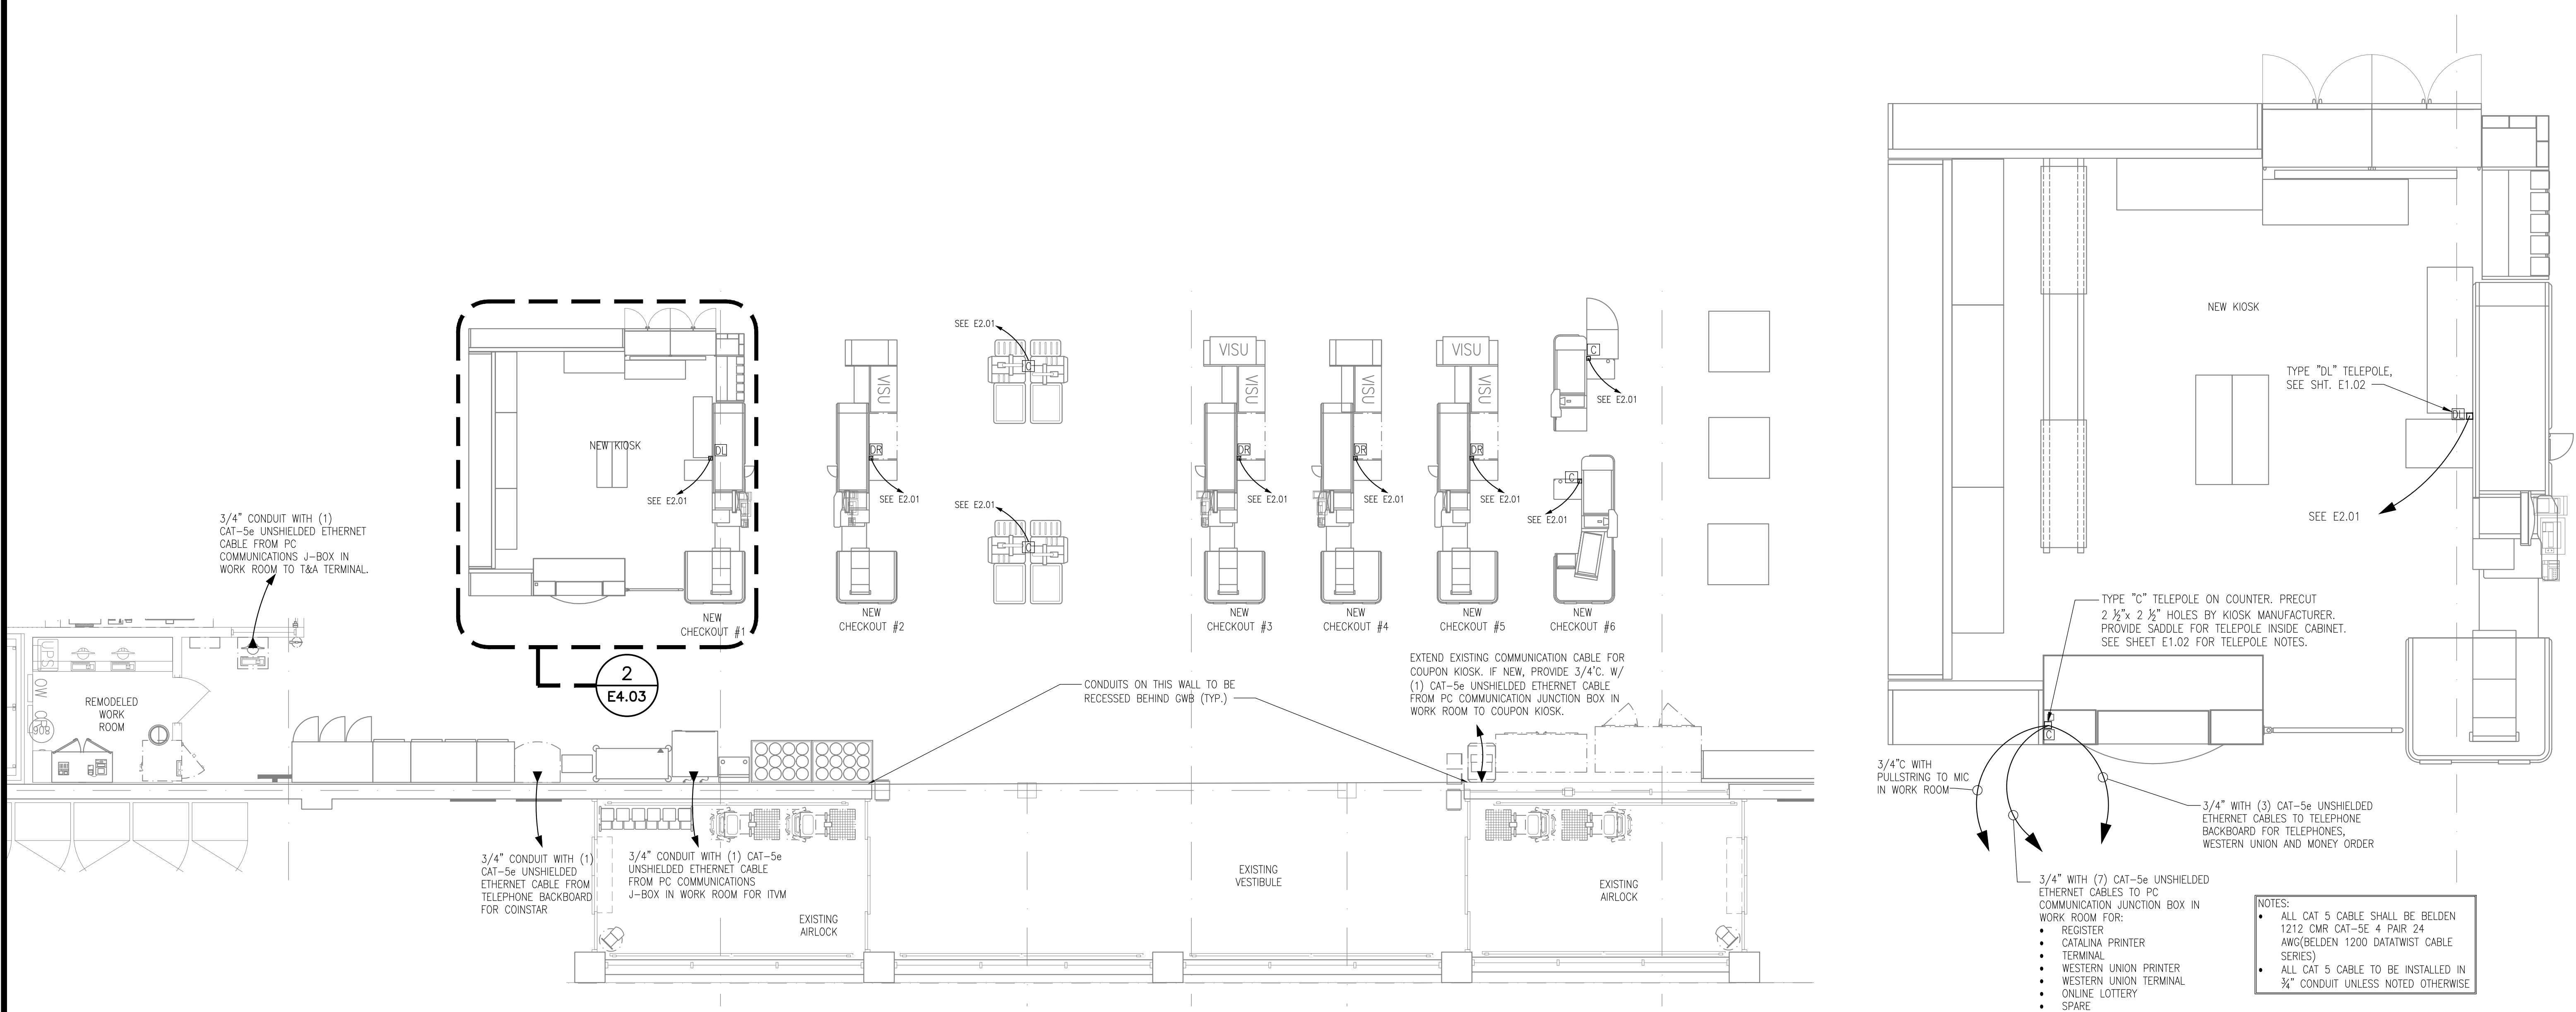

1 ENLARGED COMMUNICATION WIRING PLAN
 E4.03 SCALE: 3/16" = 1'-0"

2 CUSTOMER SERVICE KIOSK COMMUNICATIONS PLAN
 E4.03 SCALE: 1/2" = 1'-0"